


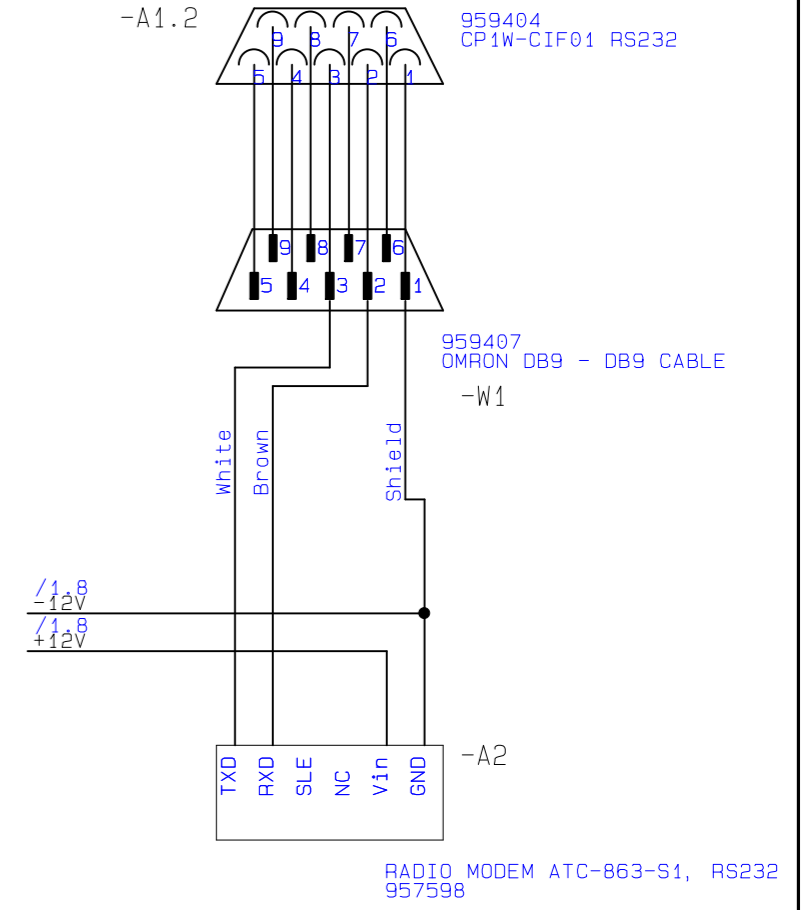
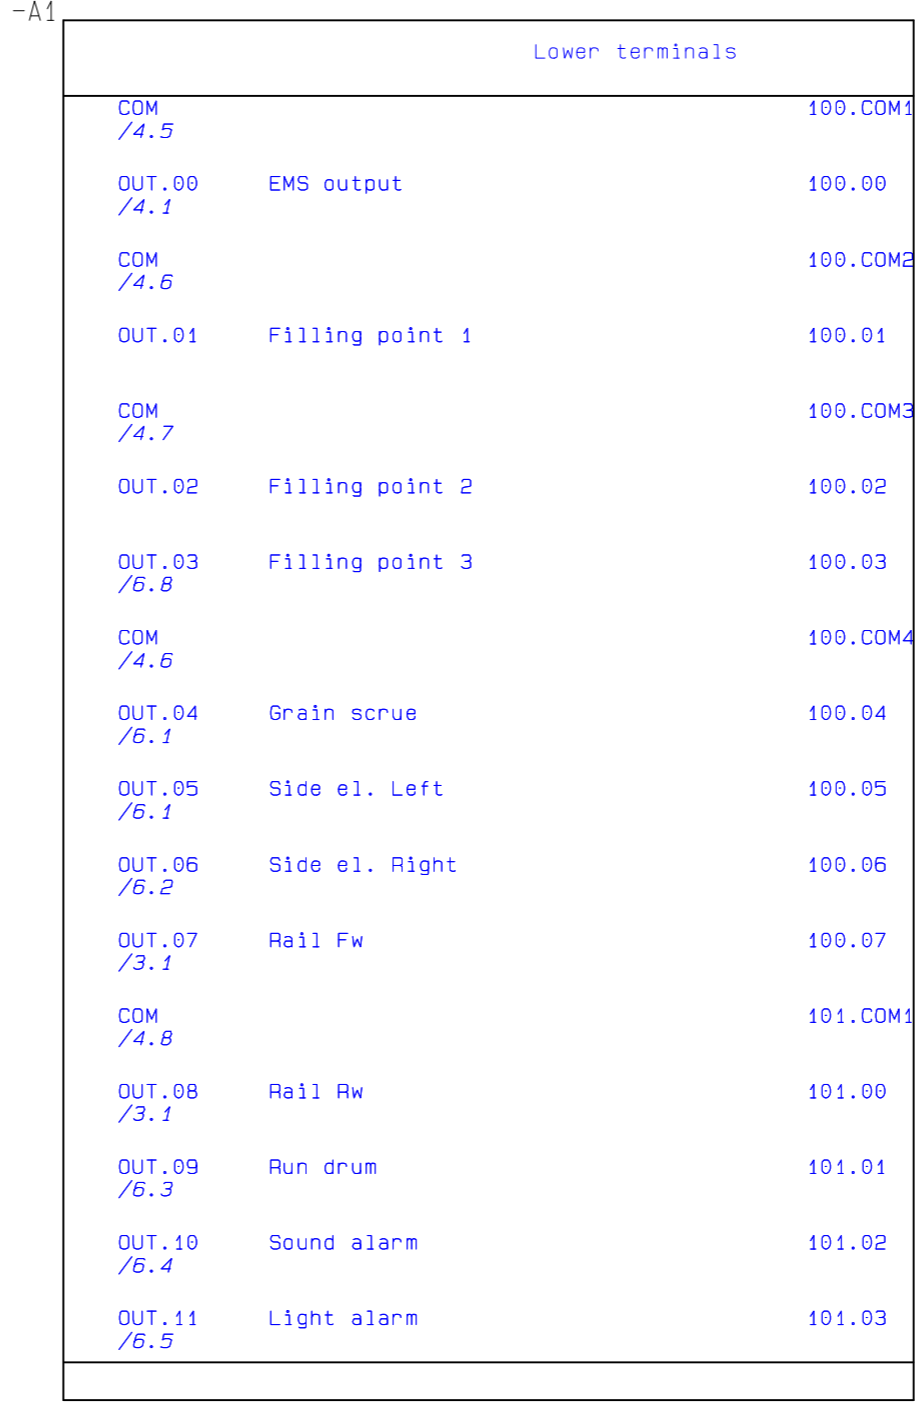


<b>Project title:</b>	<b>EF2016V001</b>	<b>Project no.:</b>	<b>Project rev.:</b>	<b>Page</b>	<b>1</b>
<b>Page title:</b>		<b>Drawing no.:</b>	<b>Page rev.:</b>	<b>Previous page:</b>	
<b>Filename:</b>	EF2016V001	<b>Constructor (project/page)</b>		<b>Last printed:</b>	26.10.2016
<b>Page ref.:</b>		<b>Appr. (date/sign.)</b>		<b>Last correction:</b>	21.10.2016
				<b>Next page:</b>	2
				<b>Number of pages:</b>	9

1 2 3 4 5 6 7 8

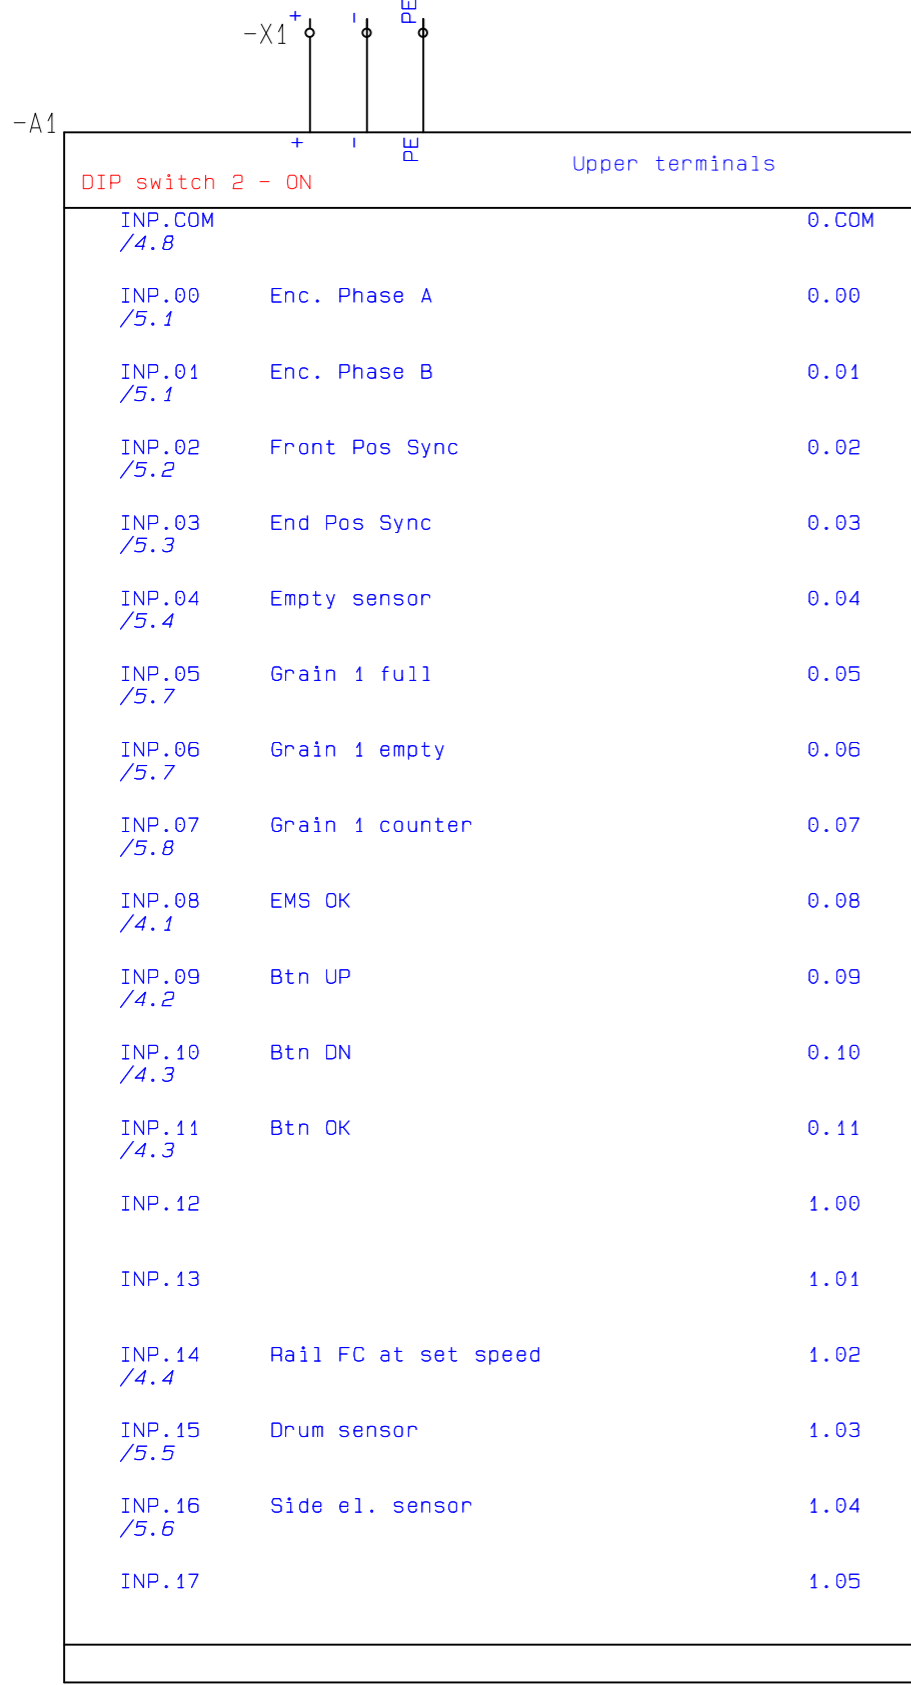

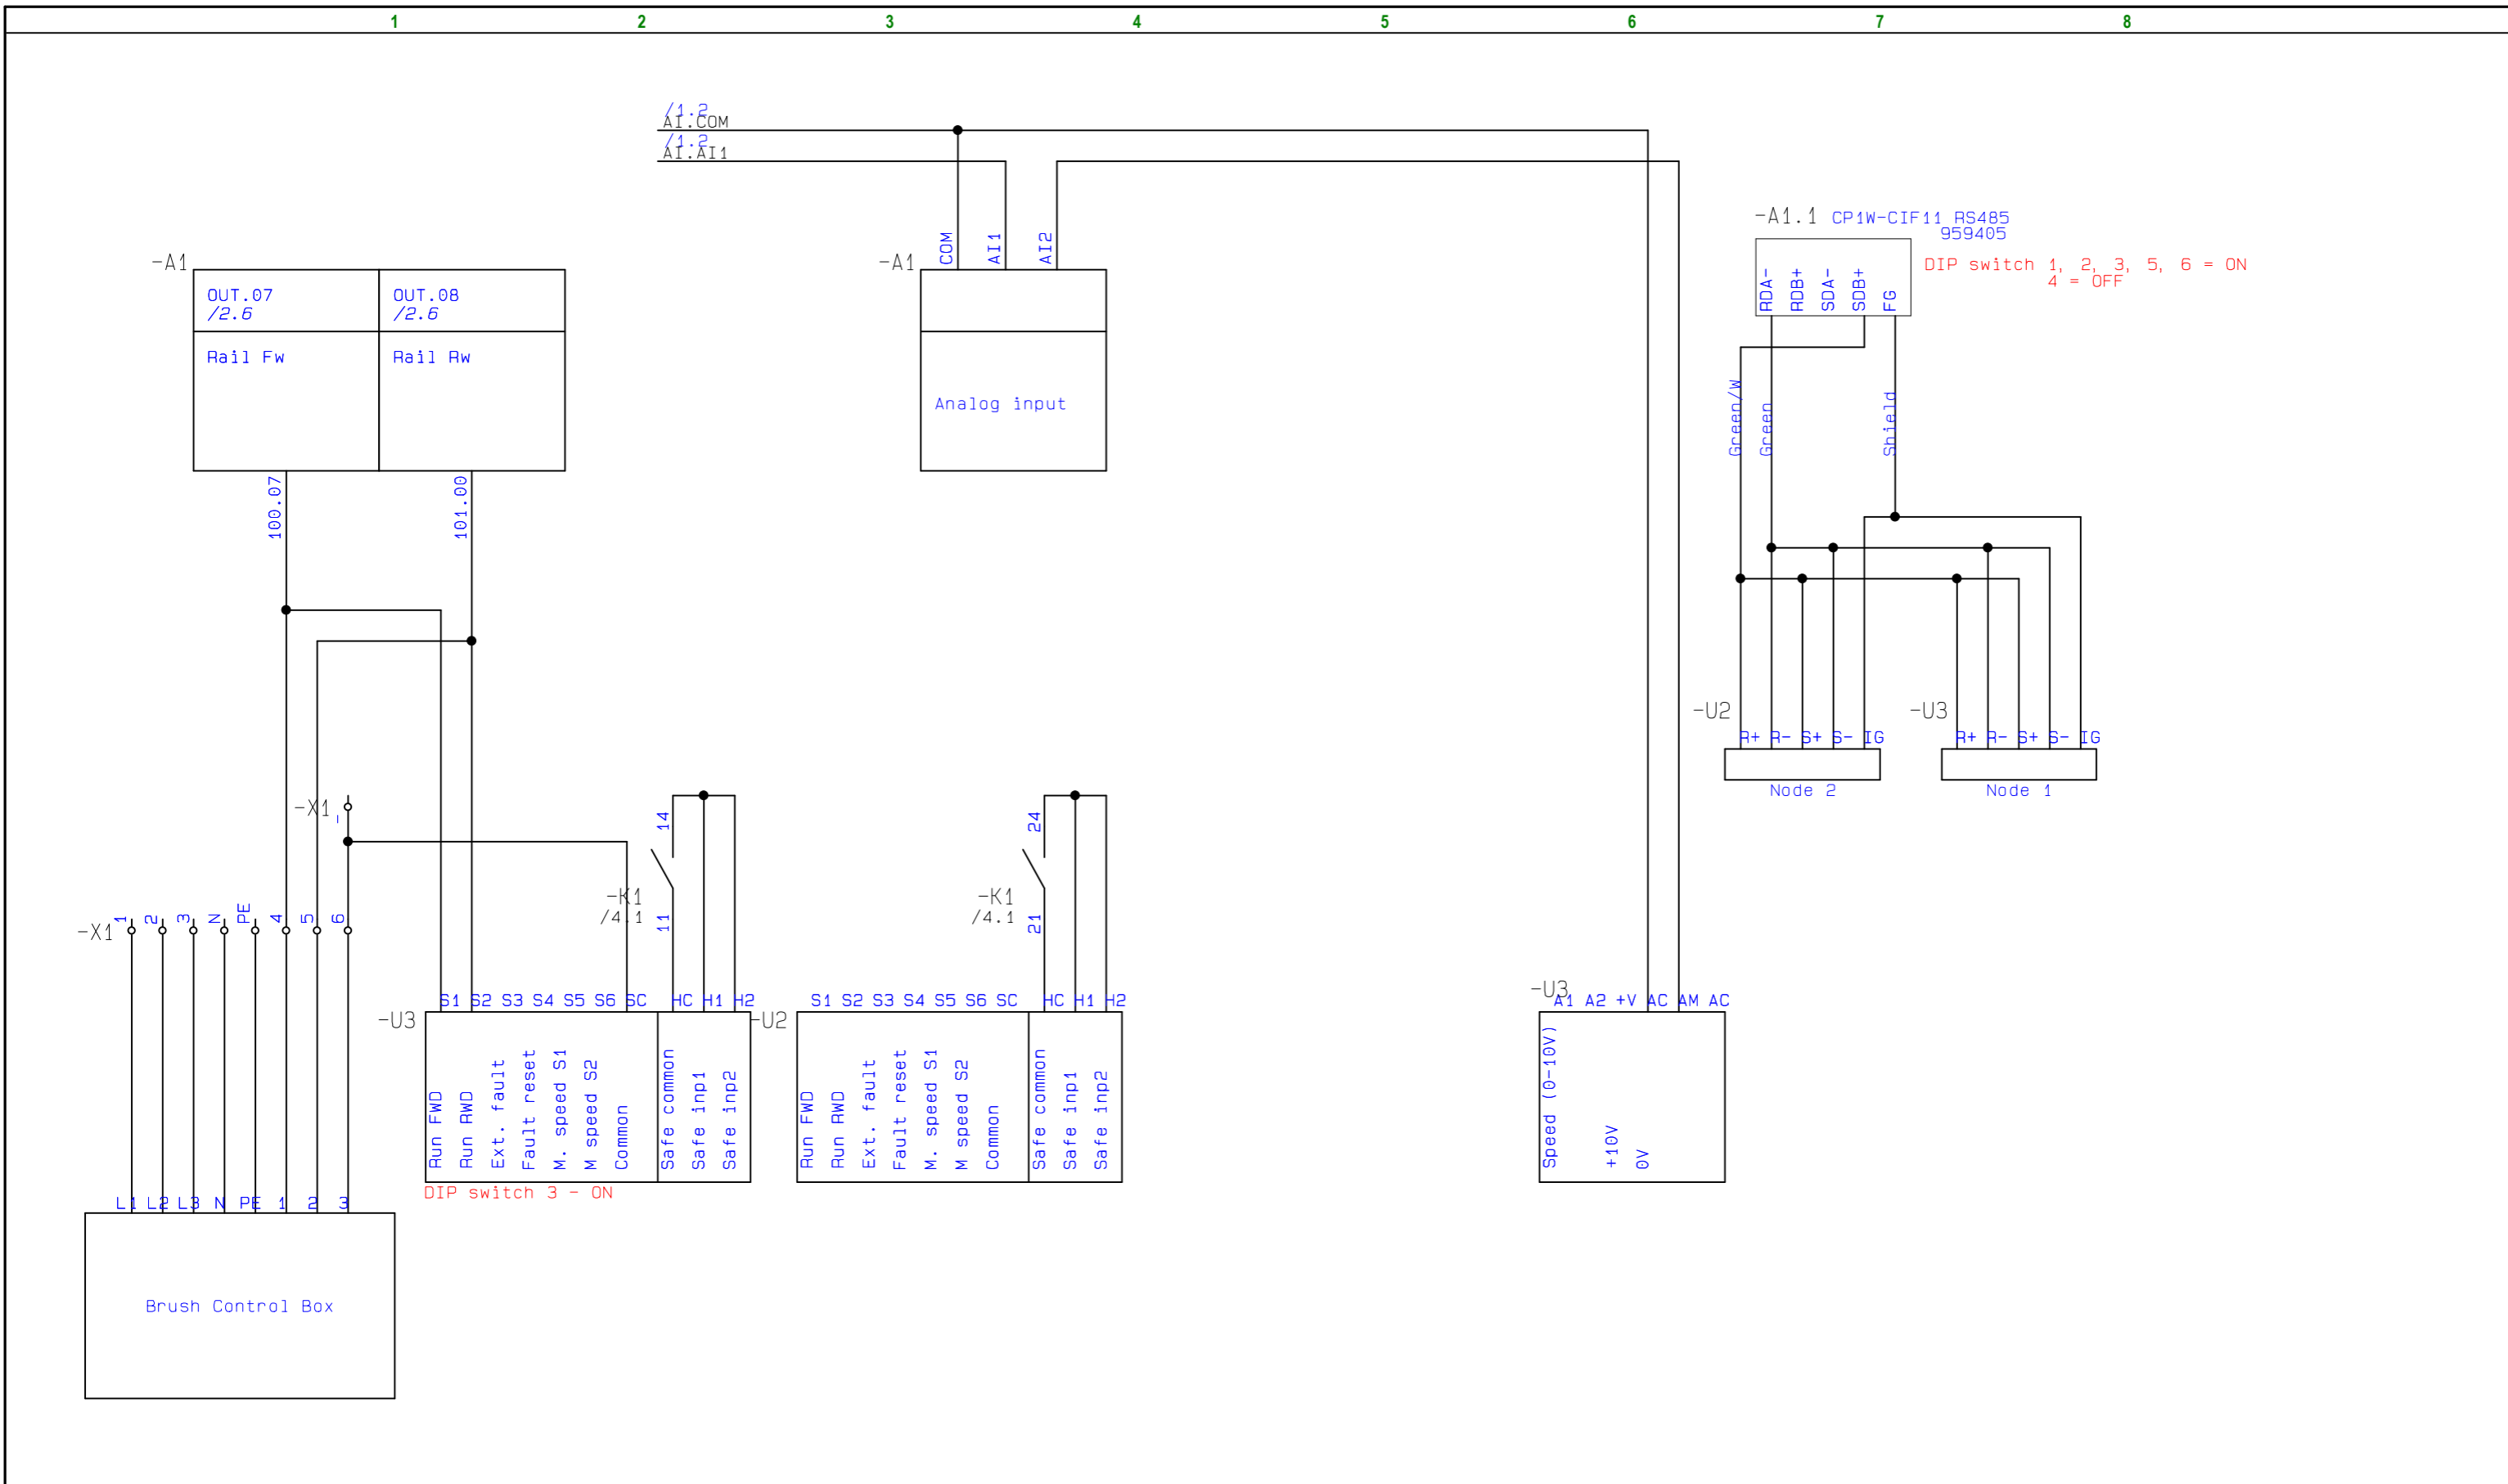

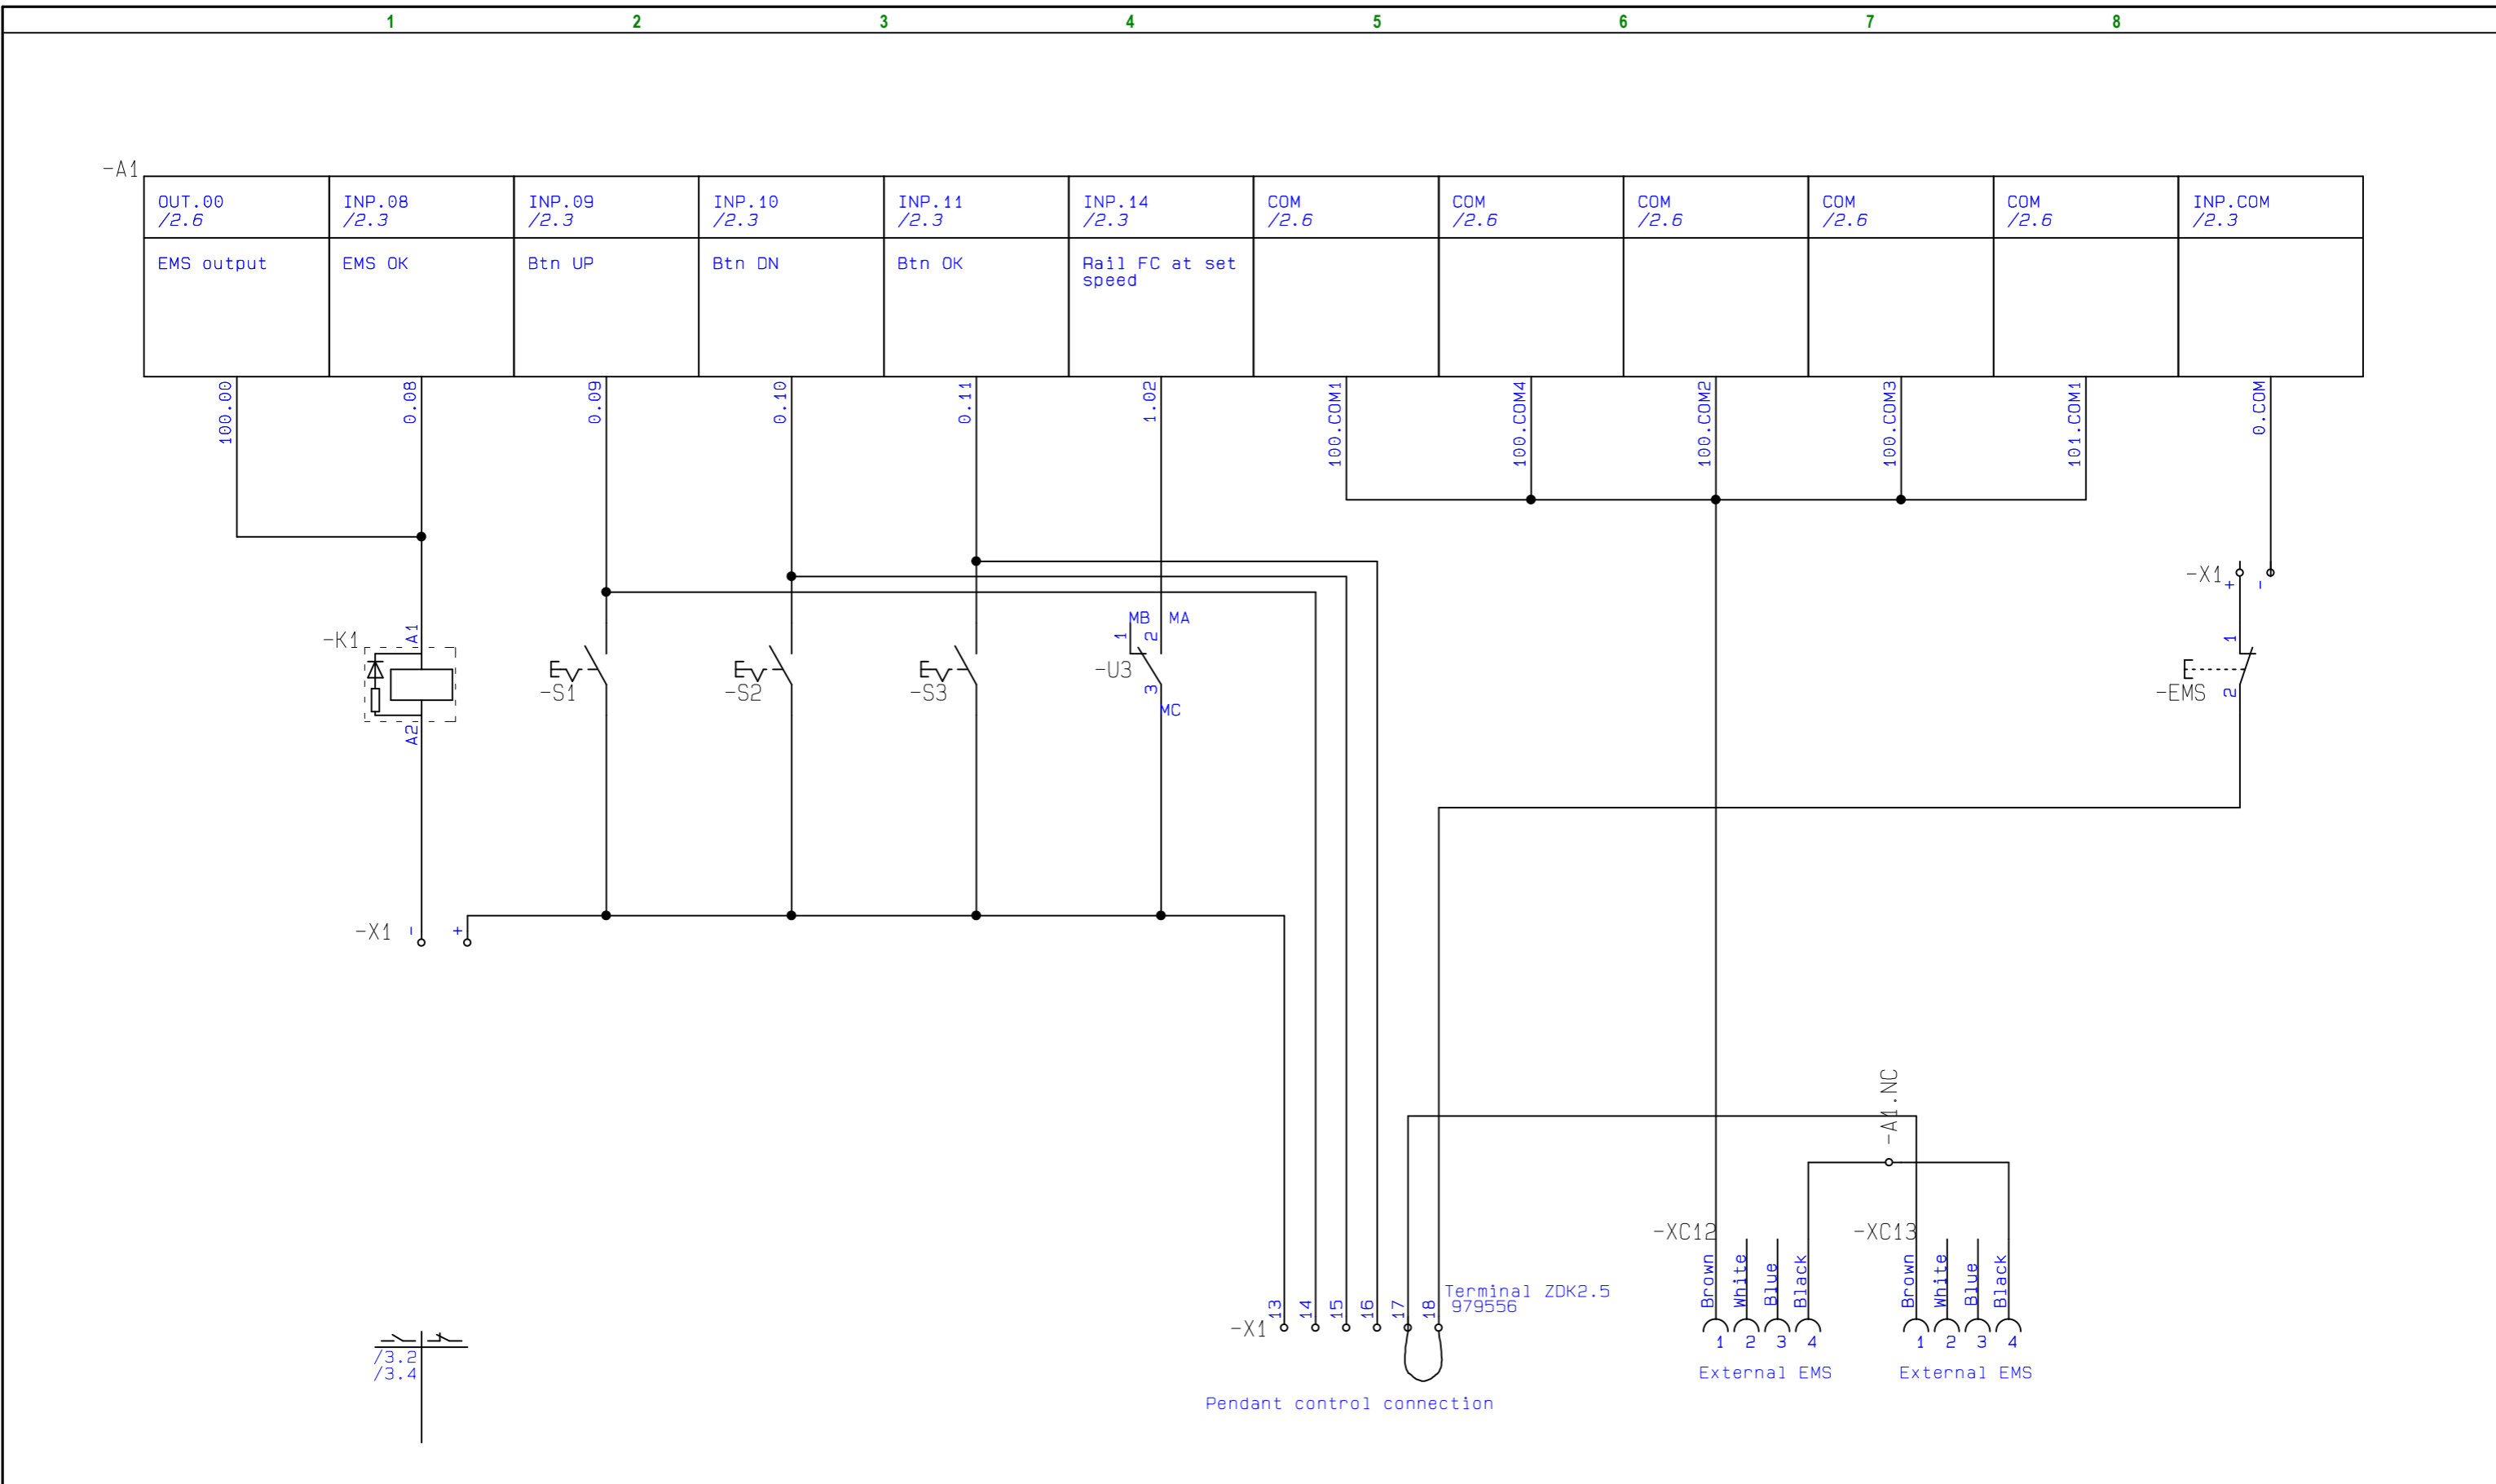



-A1


INP.00 /2.3	INP.01 /2.3	INP.02 /2.3	INP.03 /2.3	INP.04 /2.3
Enc. Phase A	Enc. Phase B	Front Pos Sync	End Pos Sync	Empty sensor

-A1

INP.15 /2.3	INP.16 /2.3	INP.05 /2.3	INP.06 /2.3	INP.07 /2.3
Drum sensor	Side el. sensor	Grain 1 full	Grain 1 empty	Grain 1 counter

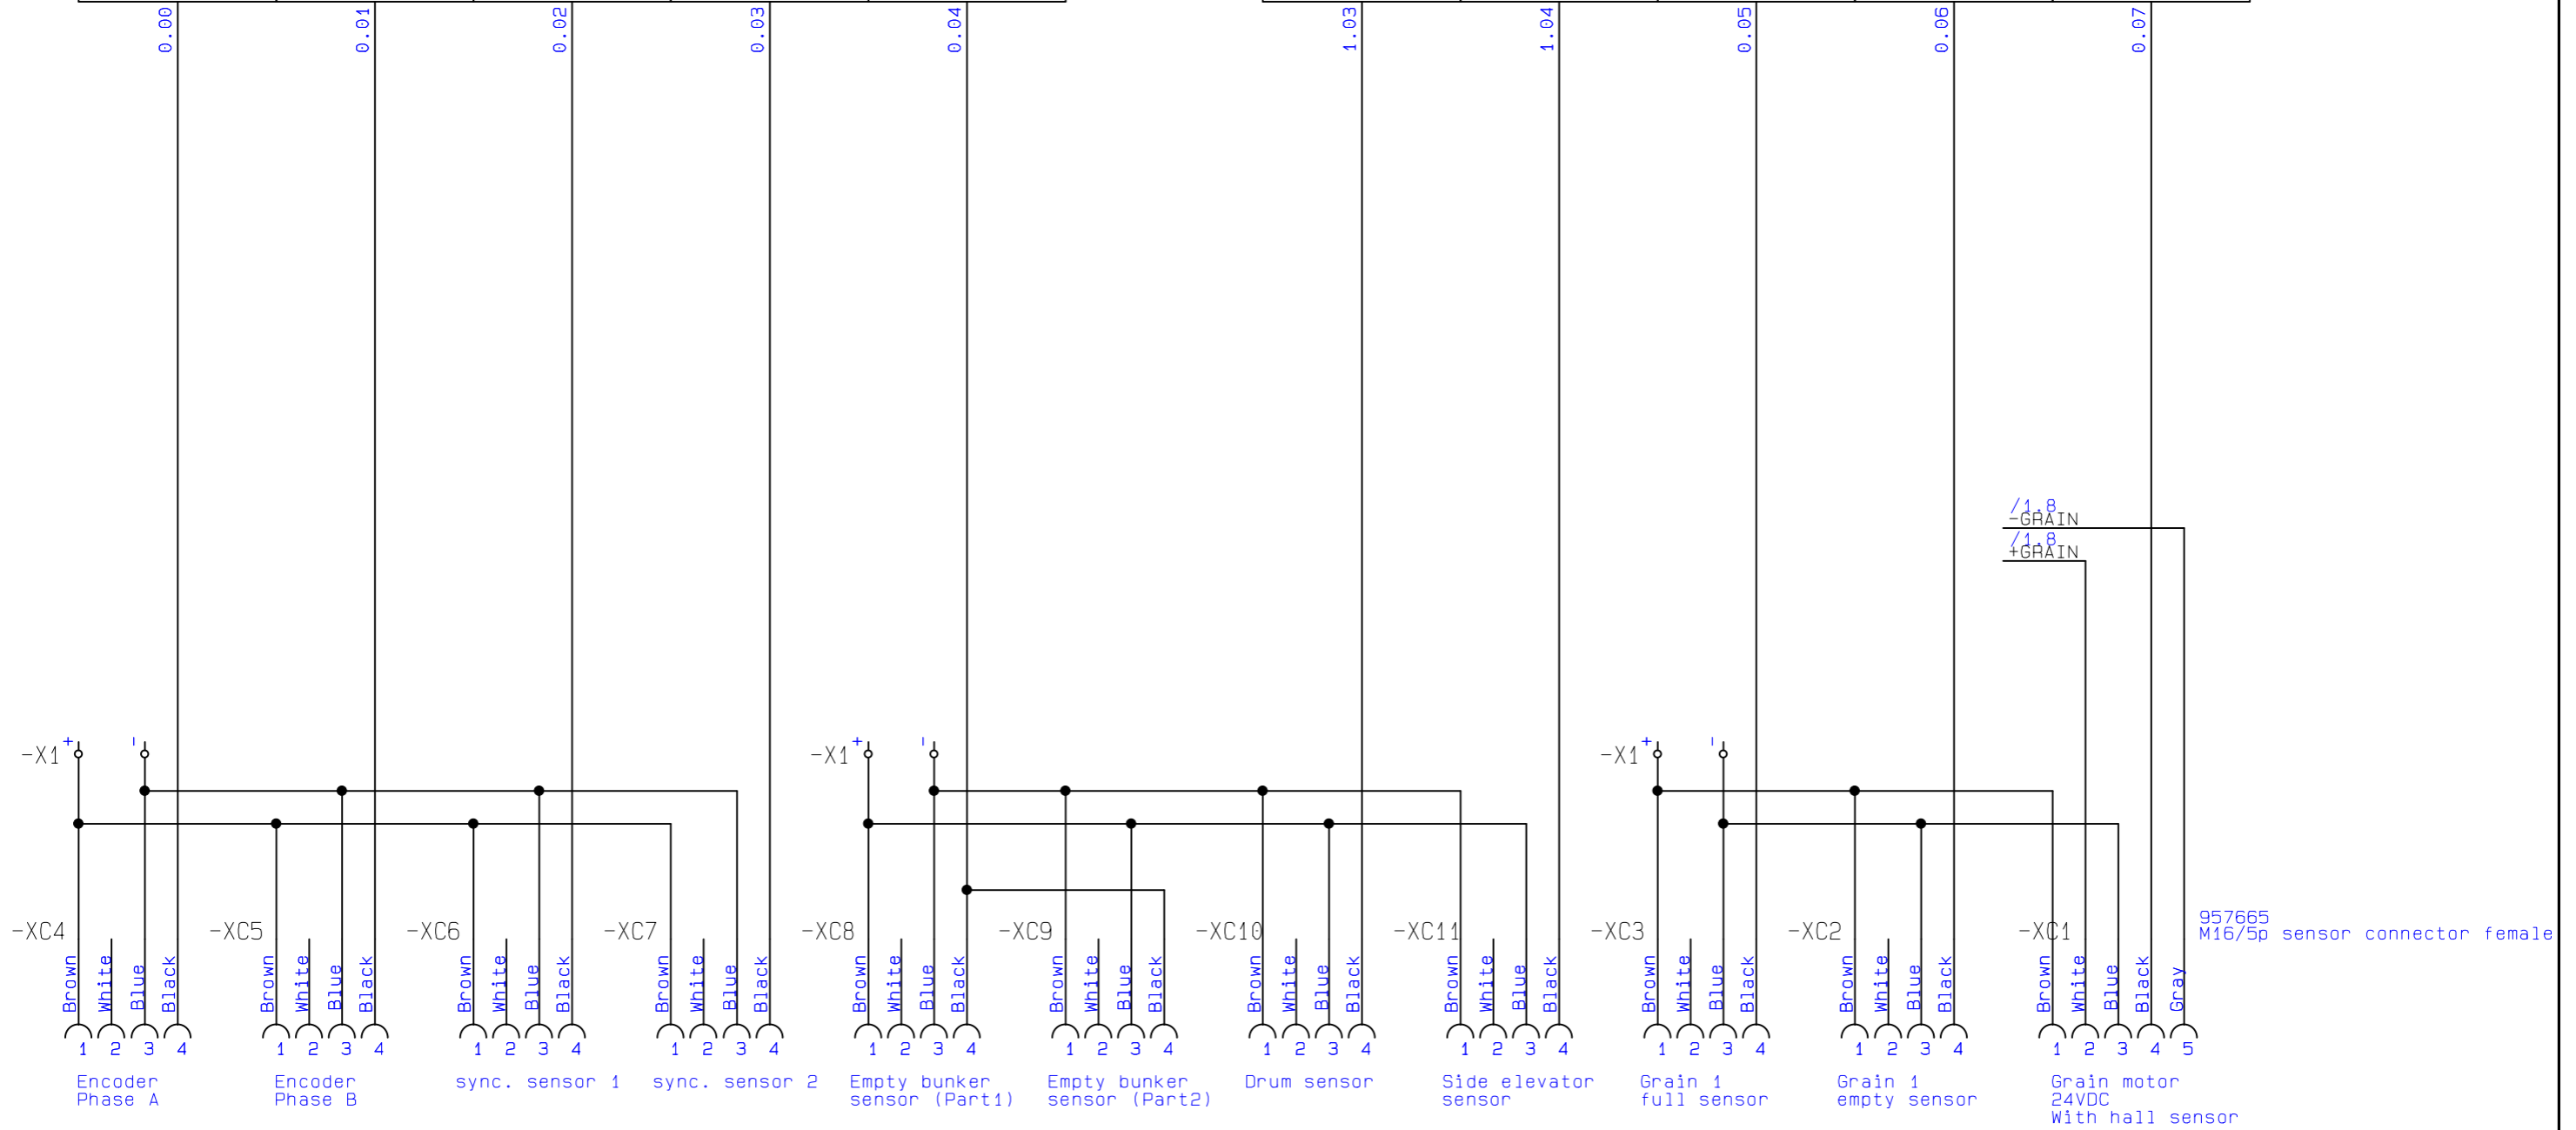

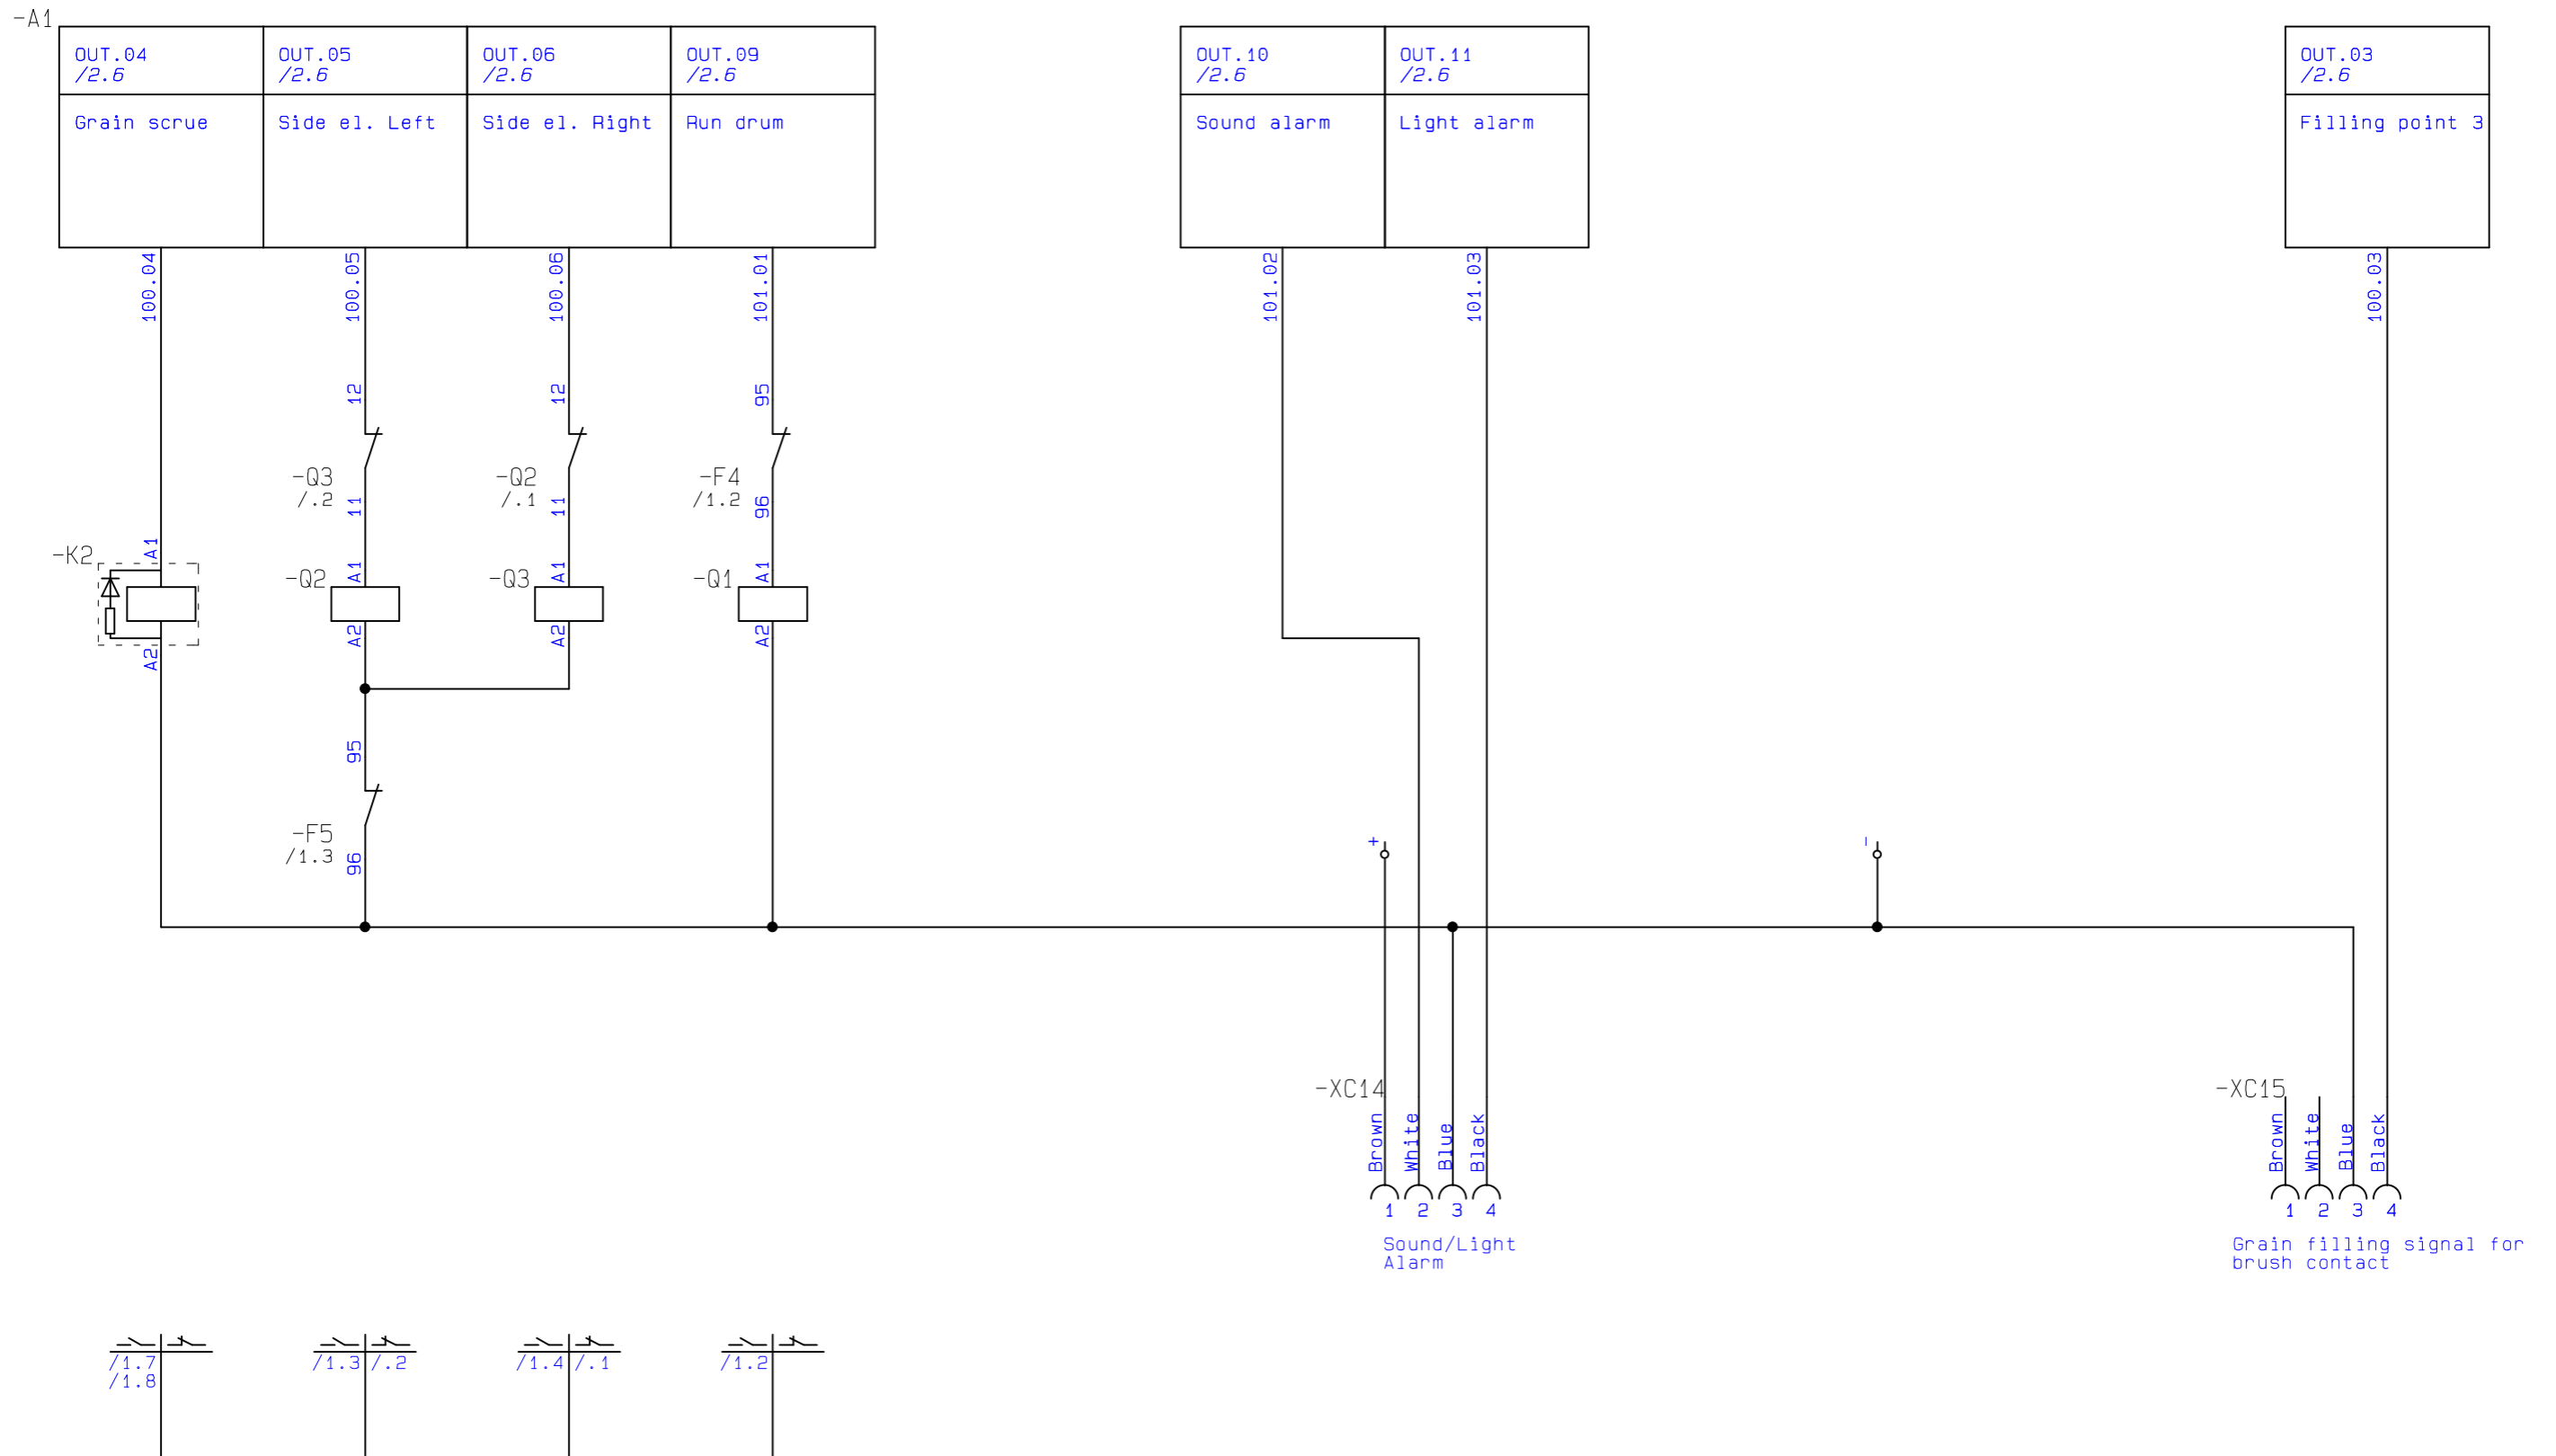

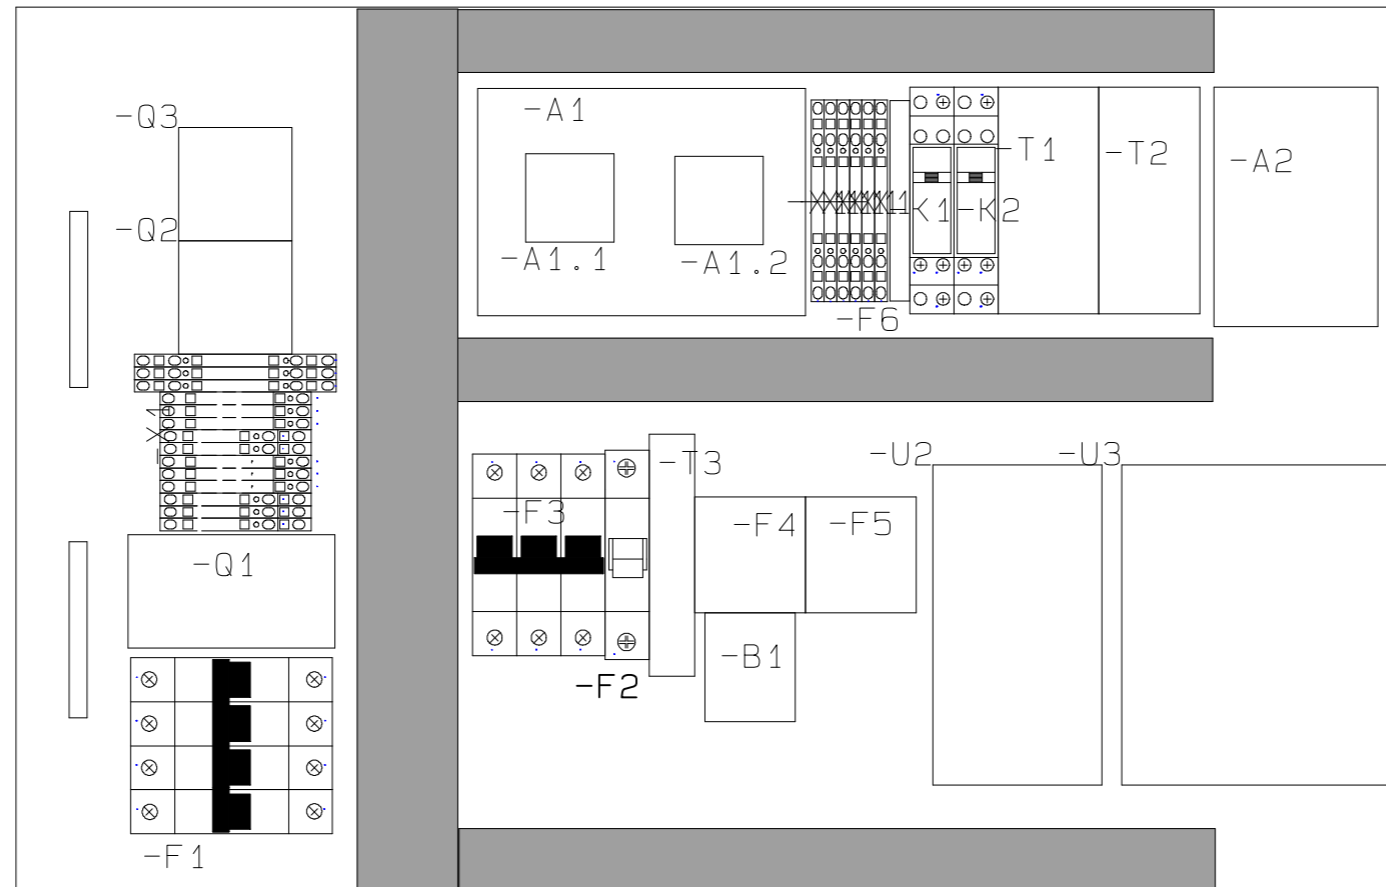

<b>Project title:</b> EF2016V001	<b>Project no.:</b>	<b>Project rev.:</b>	<b>Page</b> 7
<b>Customer:</b>	<b>DCC:</b>		<b>Scale:</b> 1:3
<b>Page title:</b> Mechanical layout (A4)	<b>Drawing no.:</b>	<b>Page rev.:</b>	<b>Previous page:</b> 6
<b>Filename:</b> EF2016V001	<b>Constructor (project/page)</b>	<b>Last printed:</b> 26.10.2016	<b>Next page:</b> 8
<b>Page ref.:</b>	<b>Appr. (date/sign.)</b>	<b>Last correction:</b> 23.02.2016	<b>Number of pages:</b> 9

1

2

3

4

5

6

7

8

